
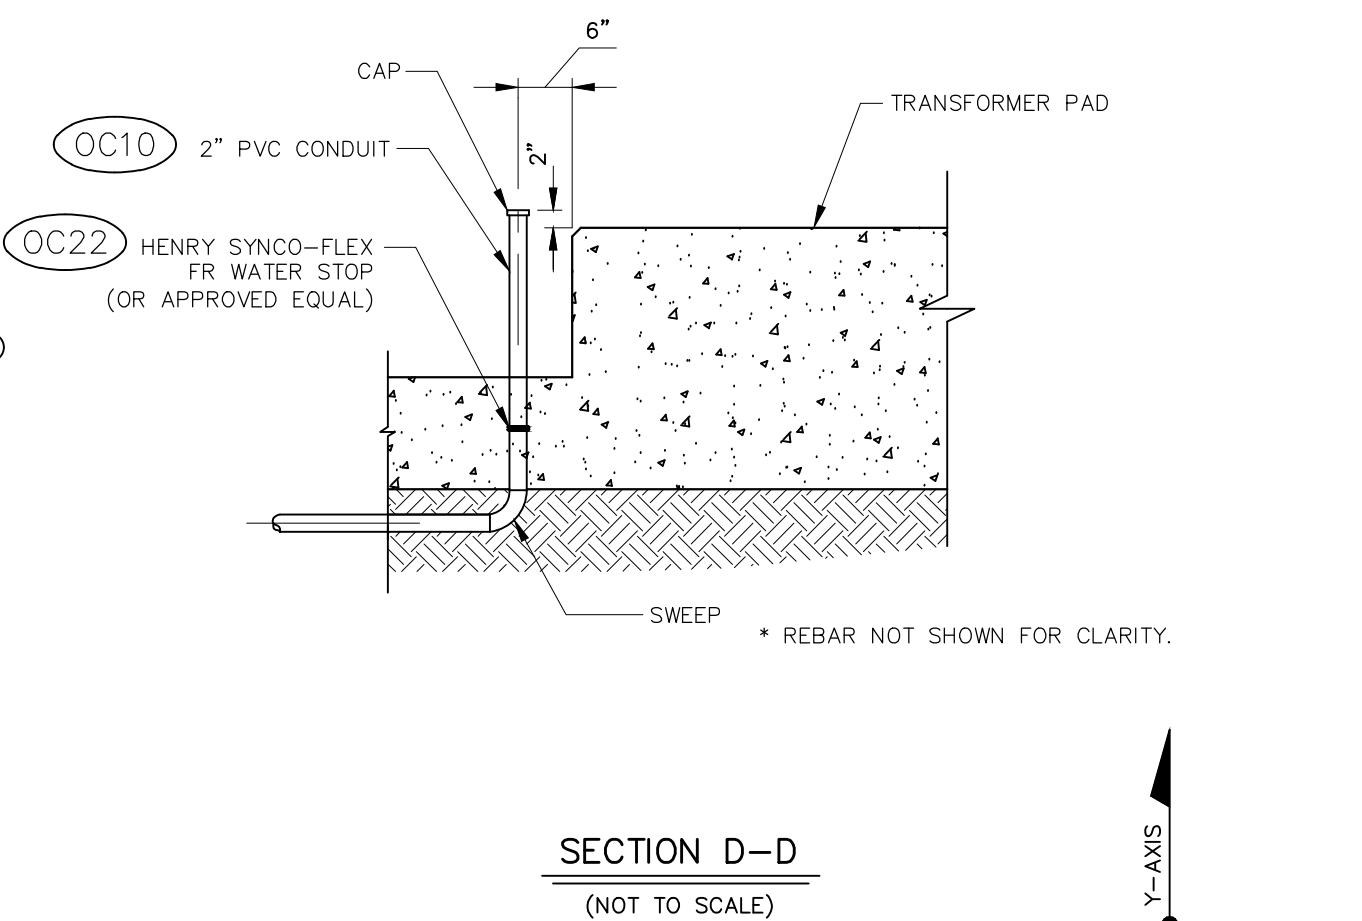
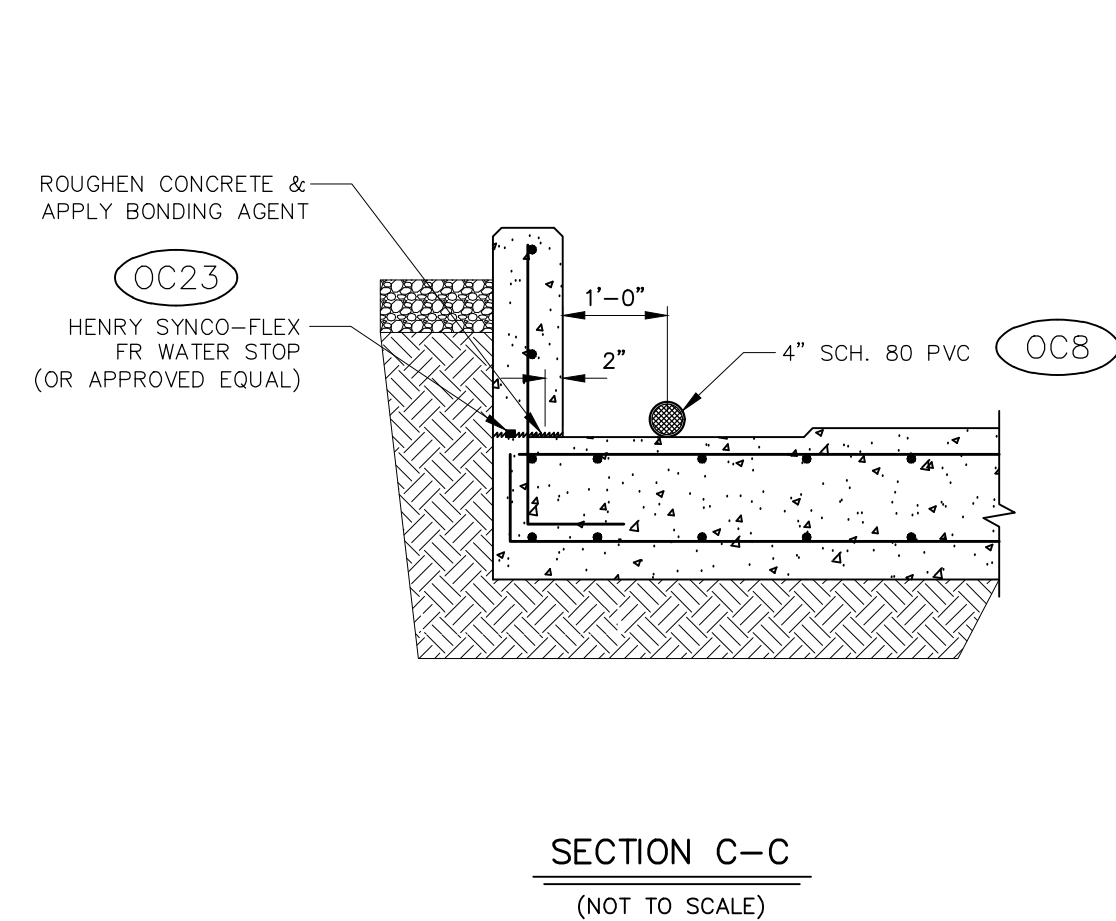
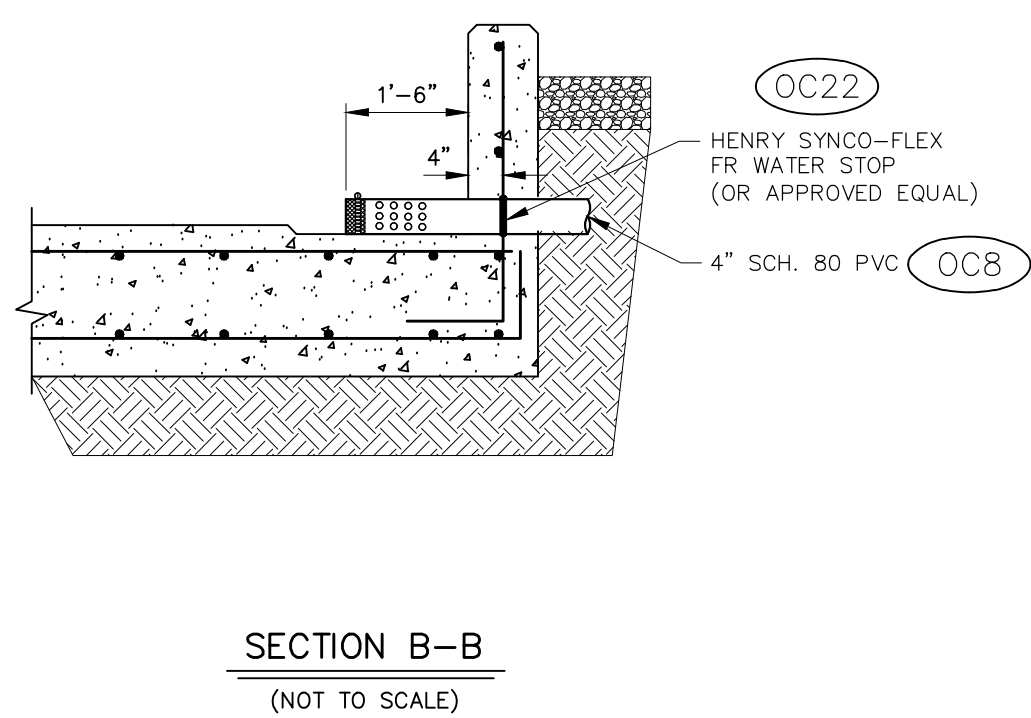
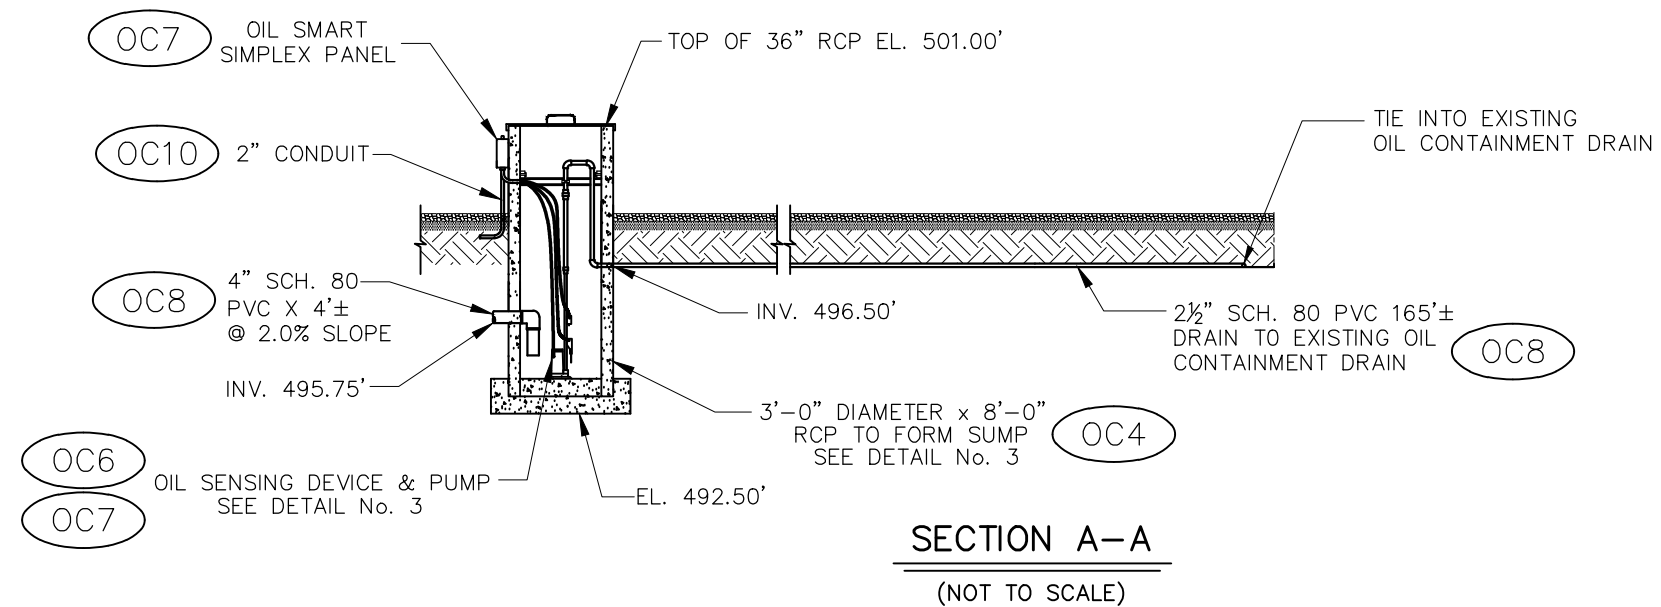
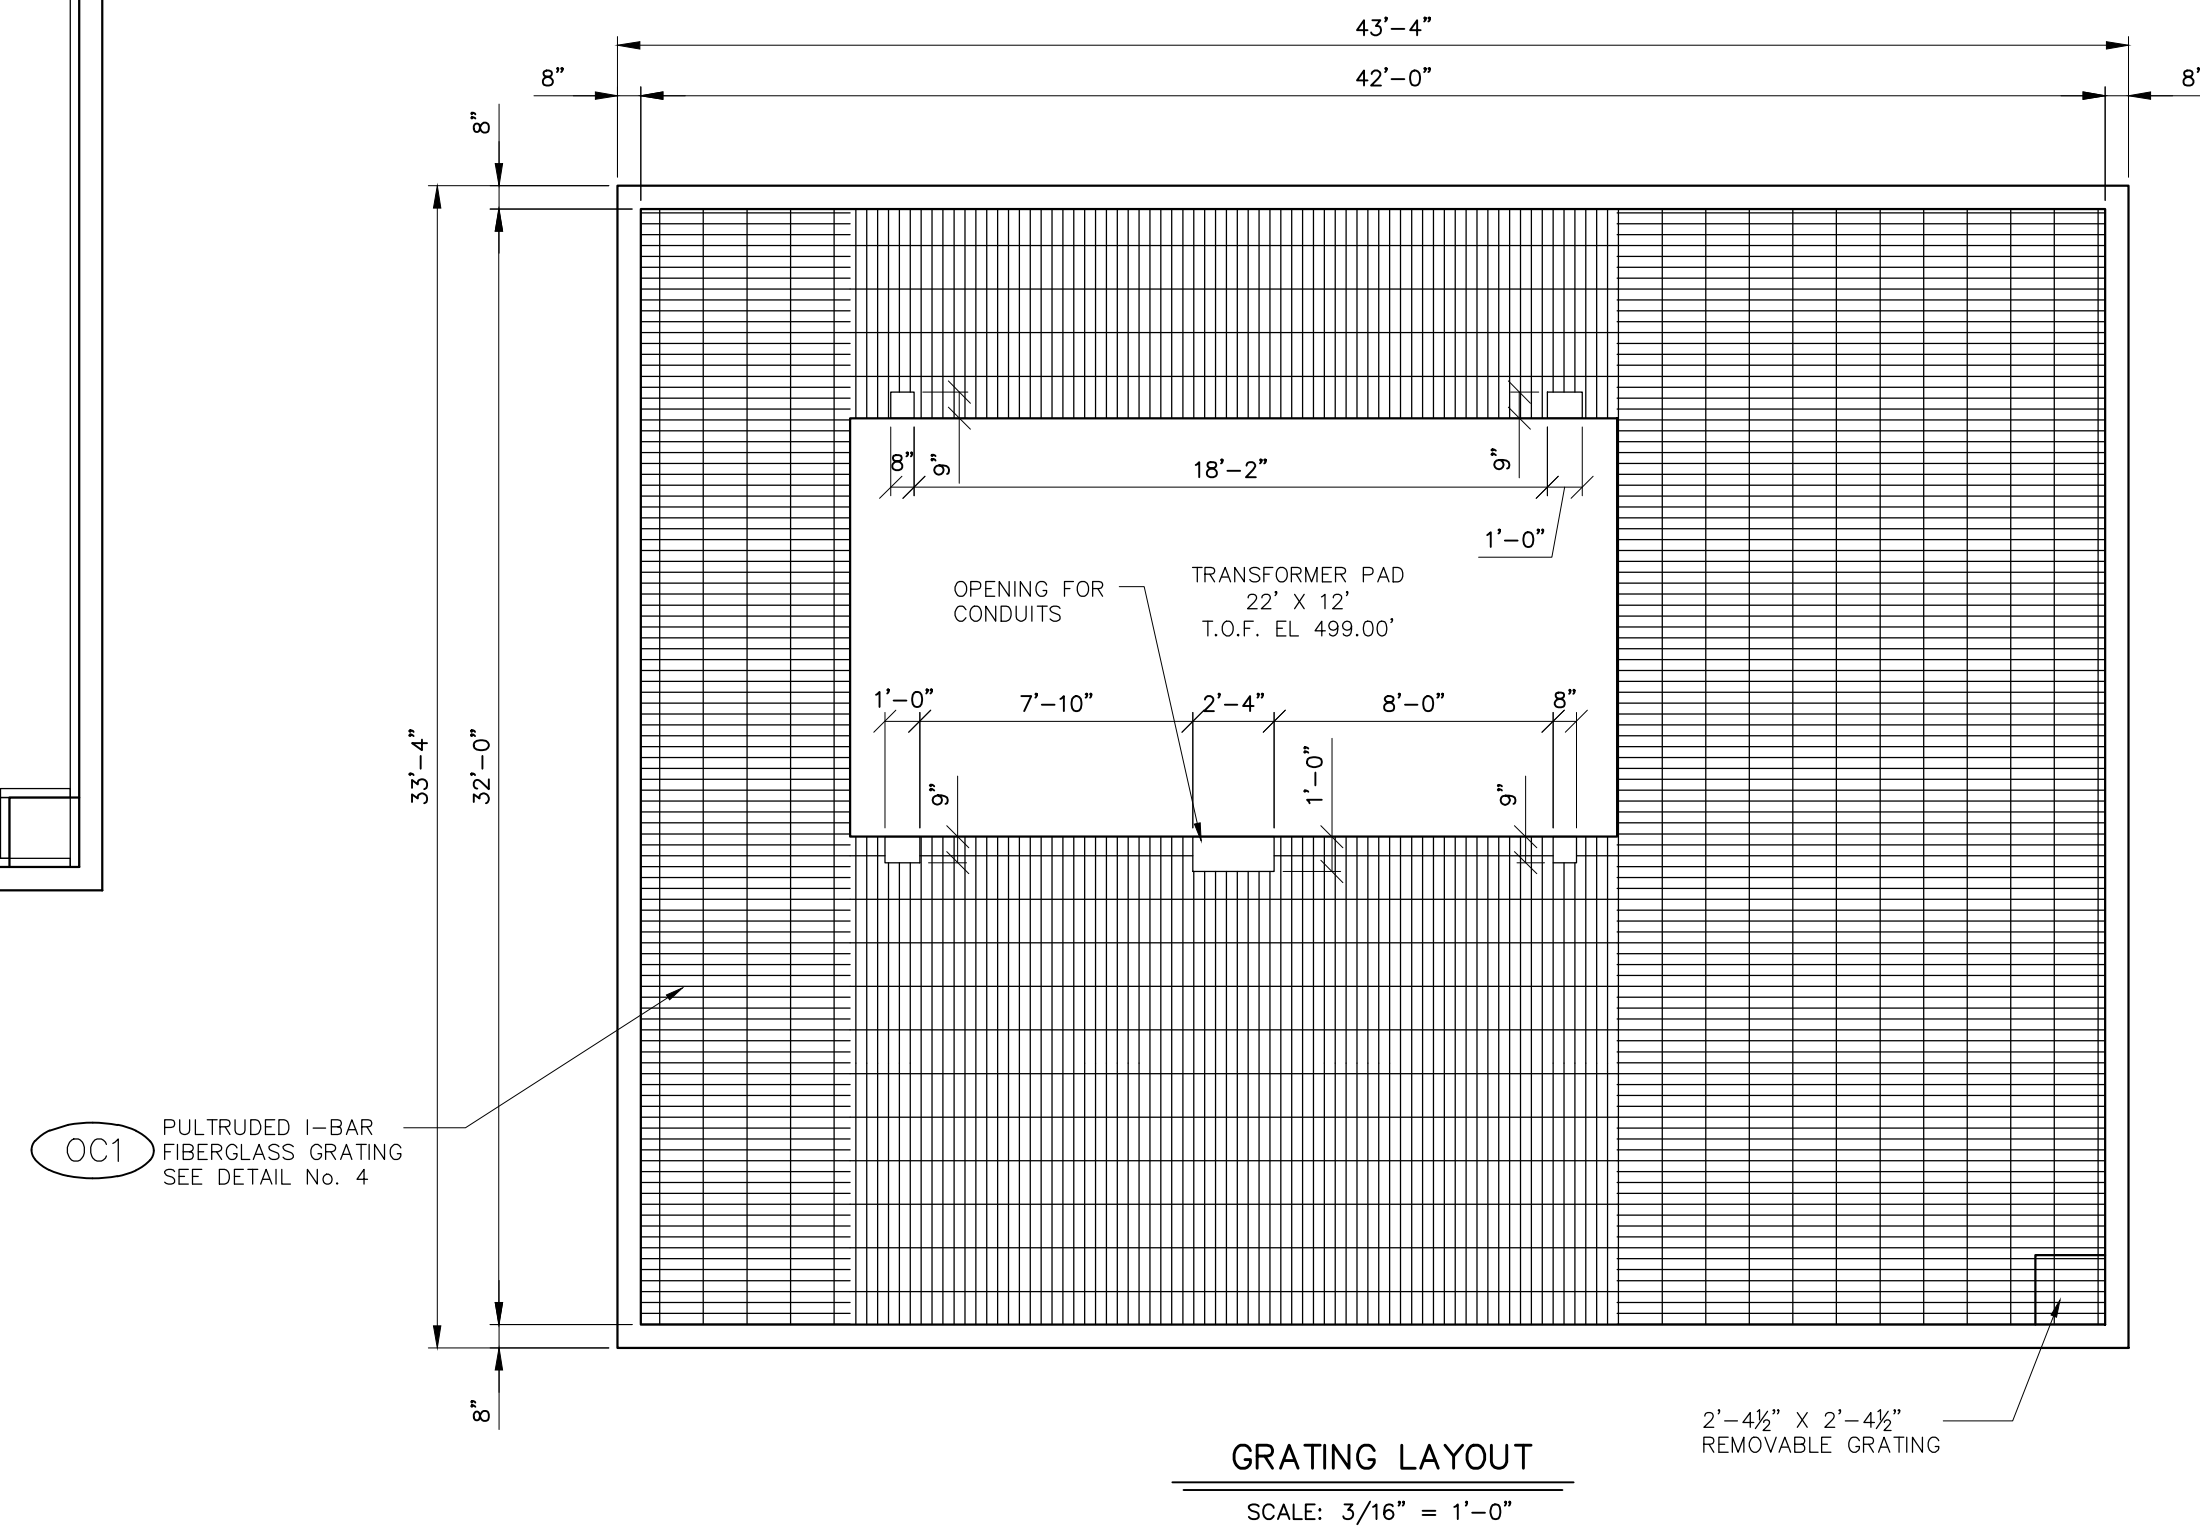
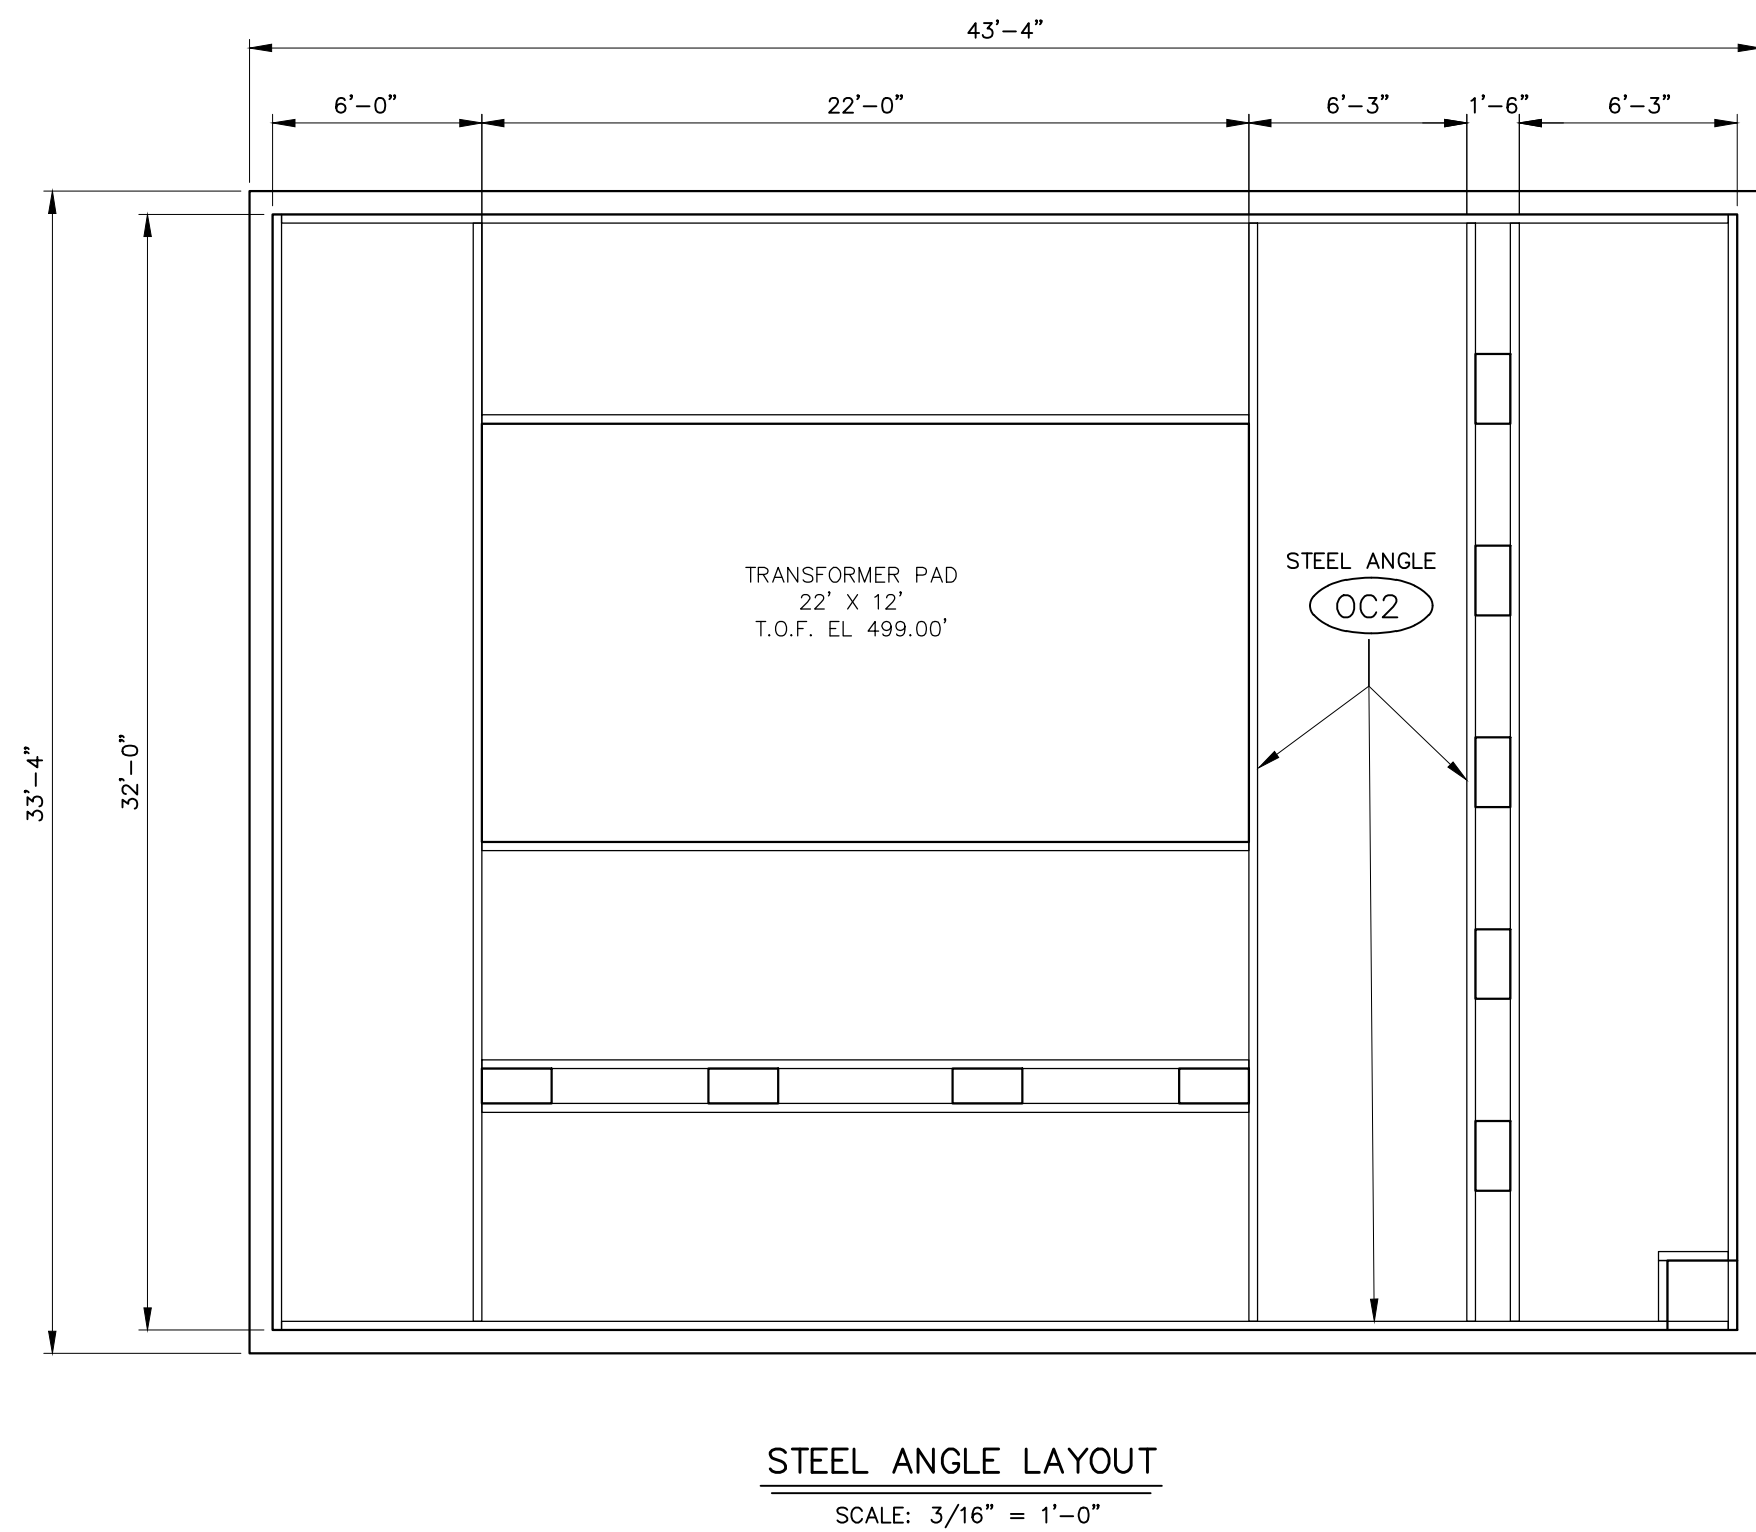


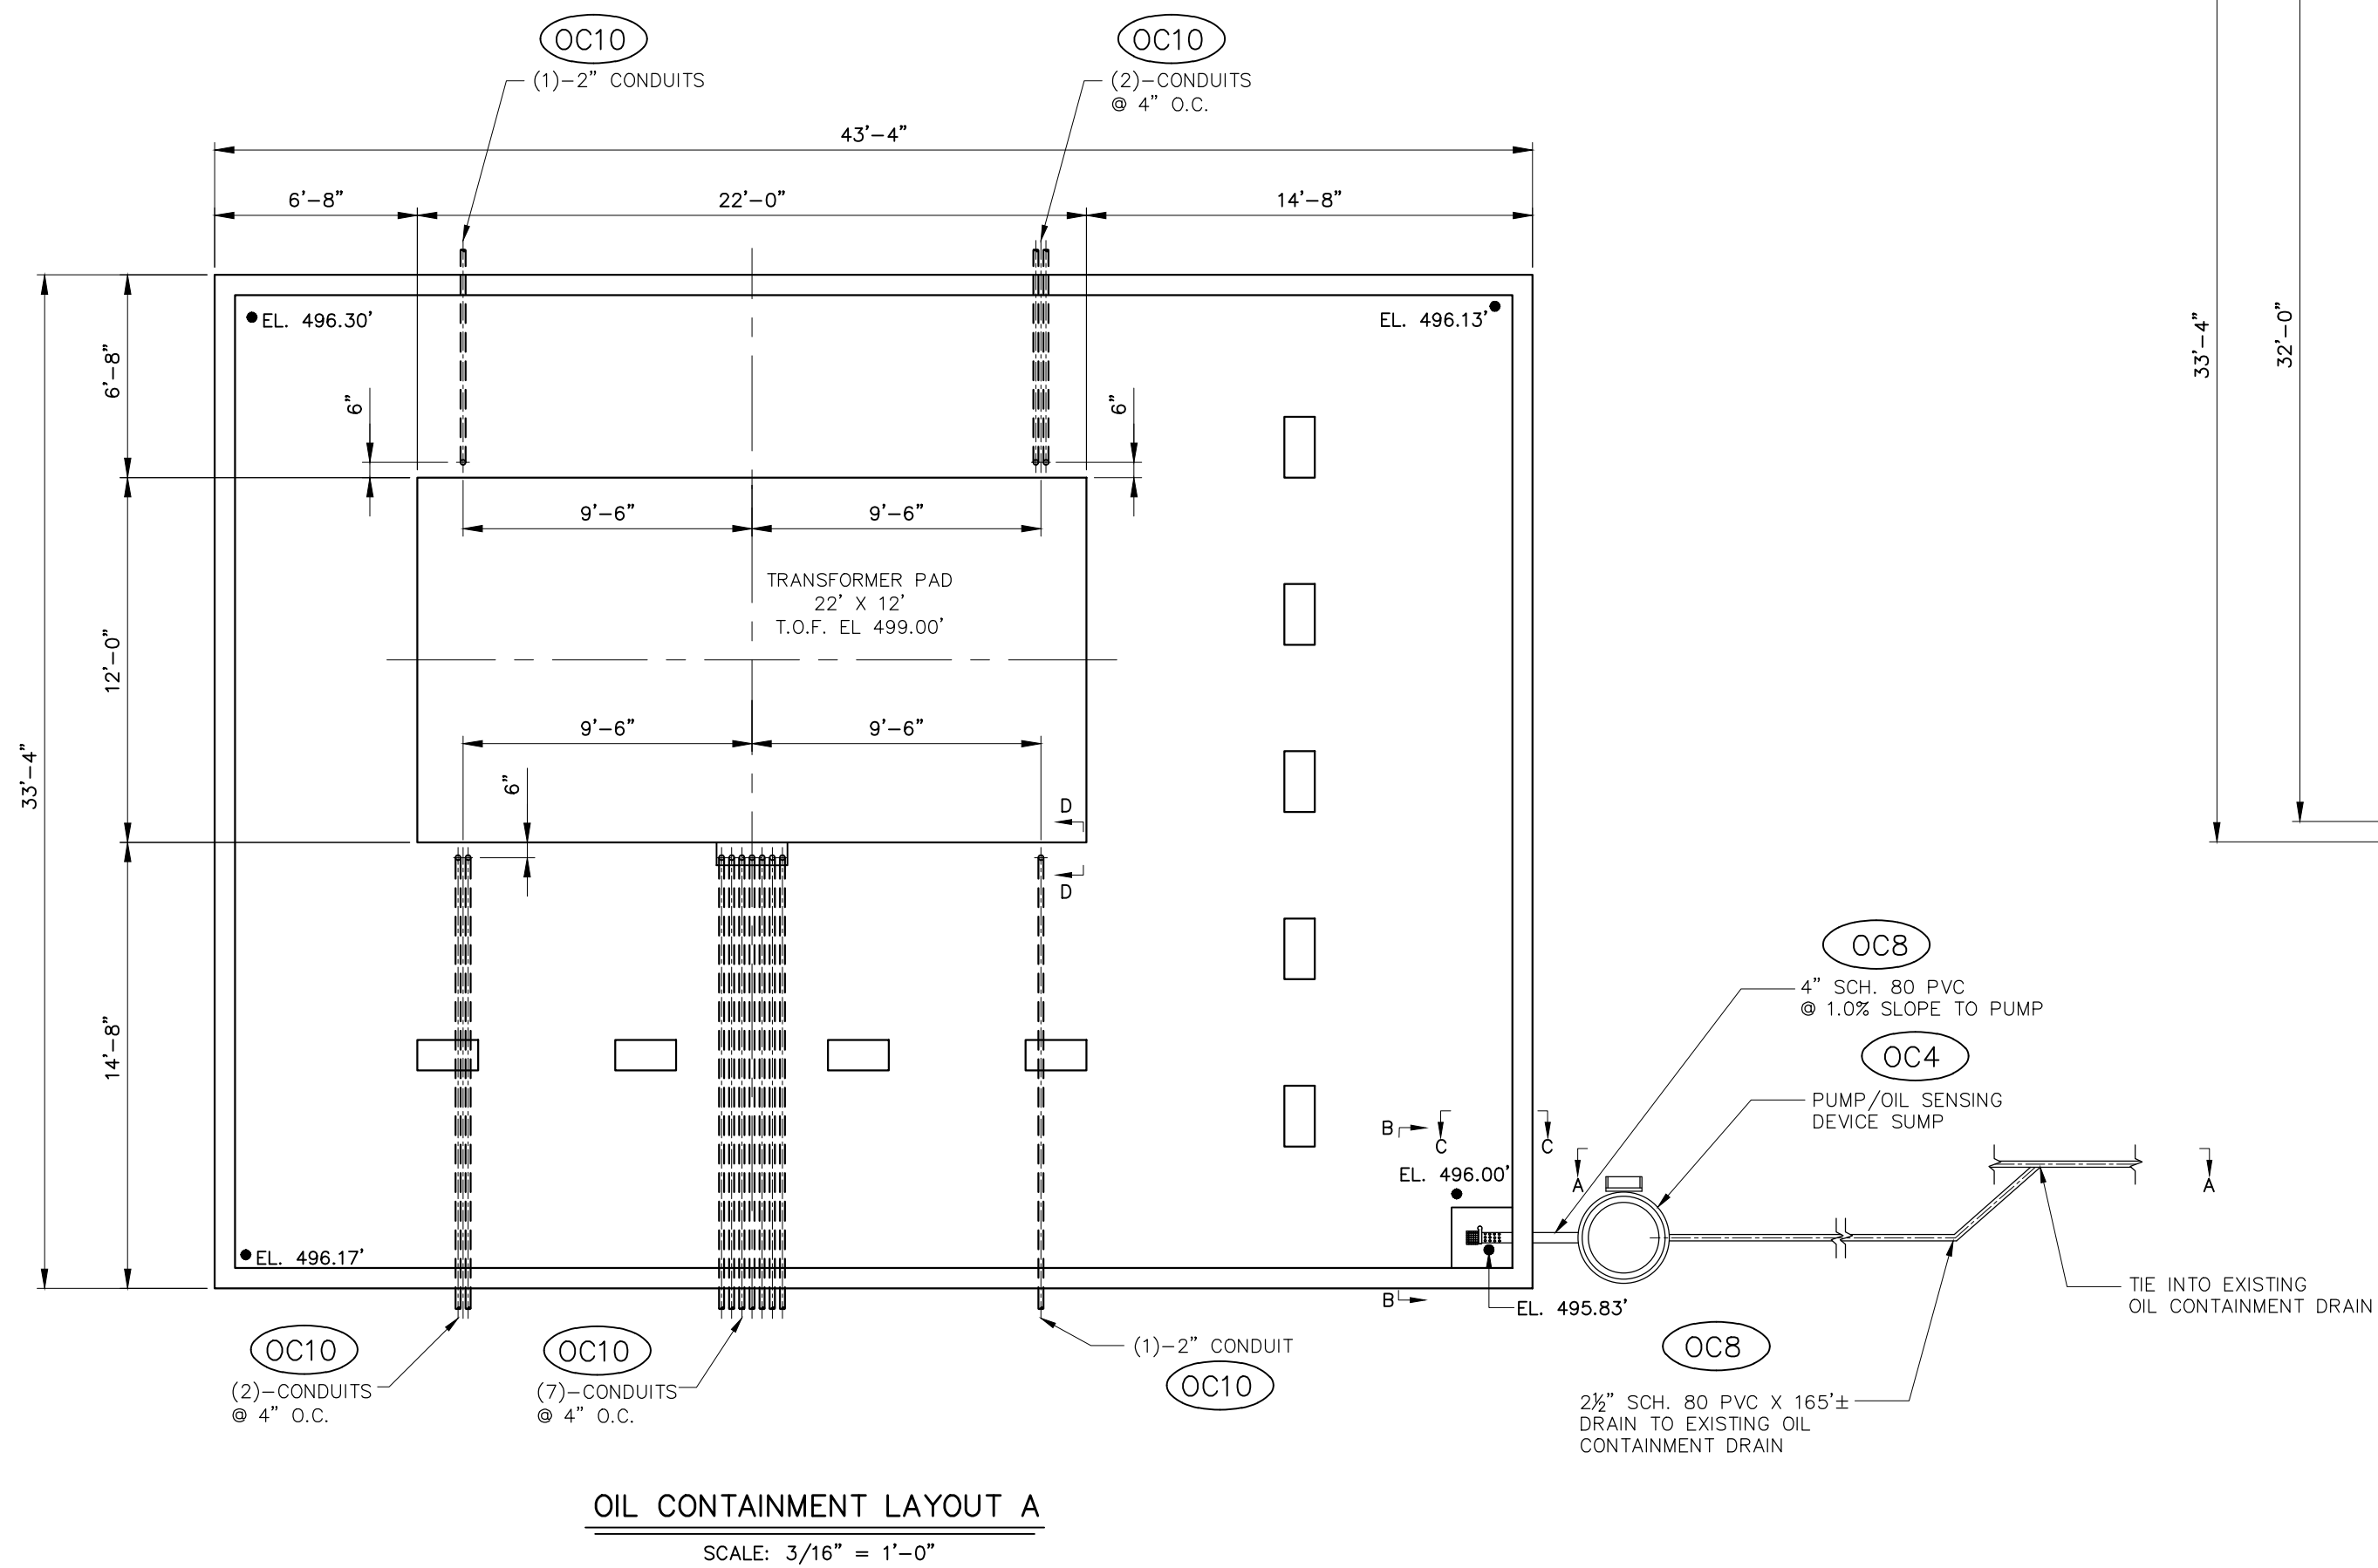

REFERENCES:

FOUNDATION PLAN	14020 FP1
OIL CONTAINMENT SYSTEM PLAN	14020 OC1 OF 3
OIL CONTAINMENT SYSTEM DETAILS	14020 OC3 OF 3

	GREENVILLE UTILITIES GREENVILLE, NORTH CAROLINA	
	GREENVILLE WEST 230kV TO 115kV SUBSTATION OIL CONTAINMENT SECTIONS	
	Booth & Associates, LLC (Professional Engineer) T. Booth, NC STATE CONSULTING ENGINEER	
	DWN. AG CKD. RSD APPD. MJM SCALE: AS NOTED	DATE: 11/28/18 DWG. NO. OC2 14020OC

0	ISSUED FOR BIDS	11/28/18
NO.	REVISIONS	DATE

© 01/17